

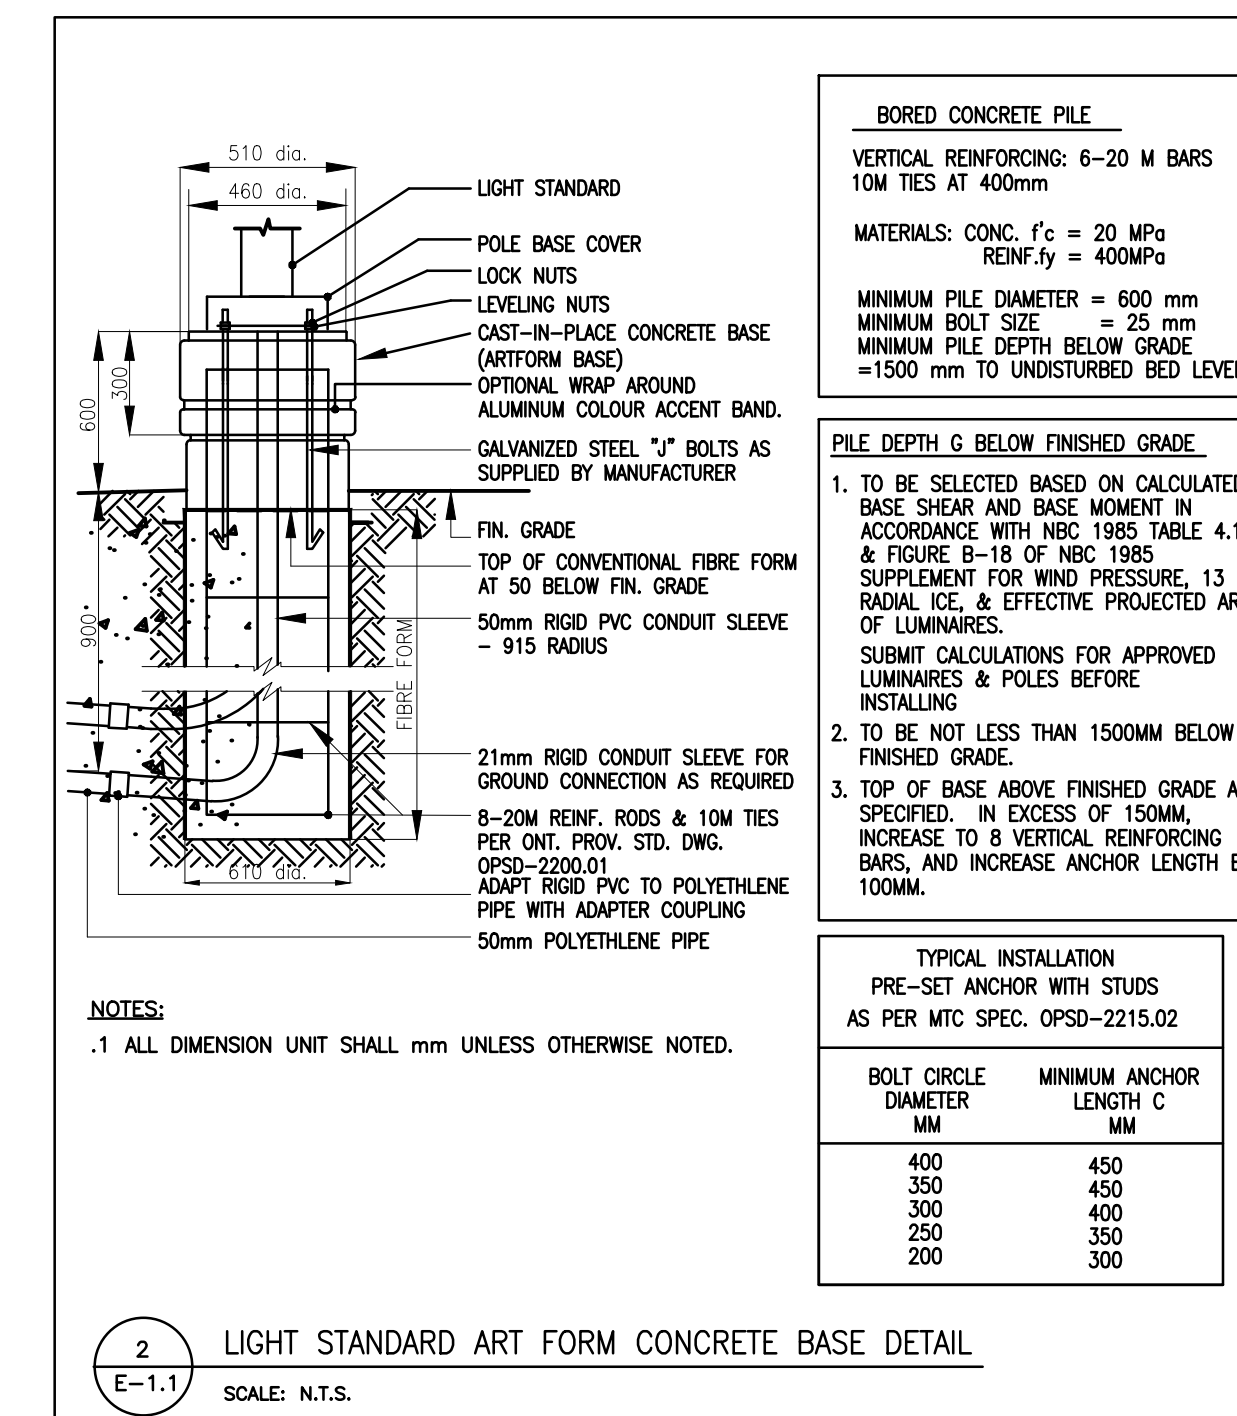
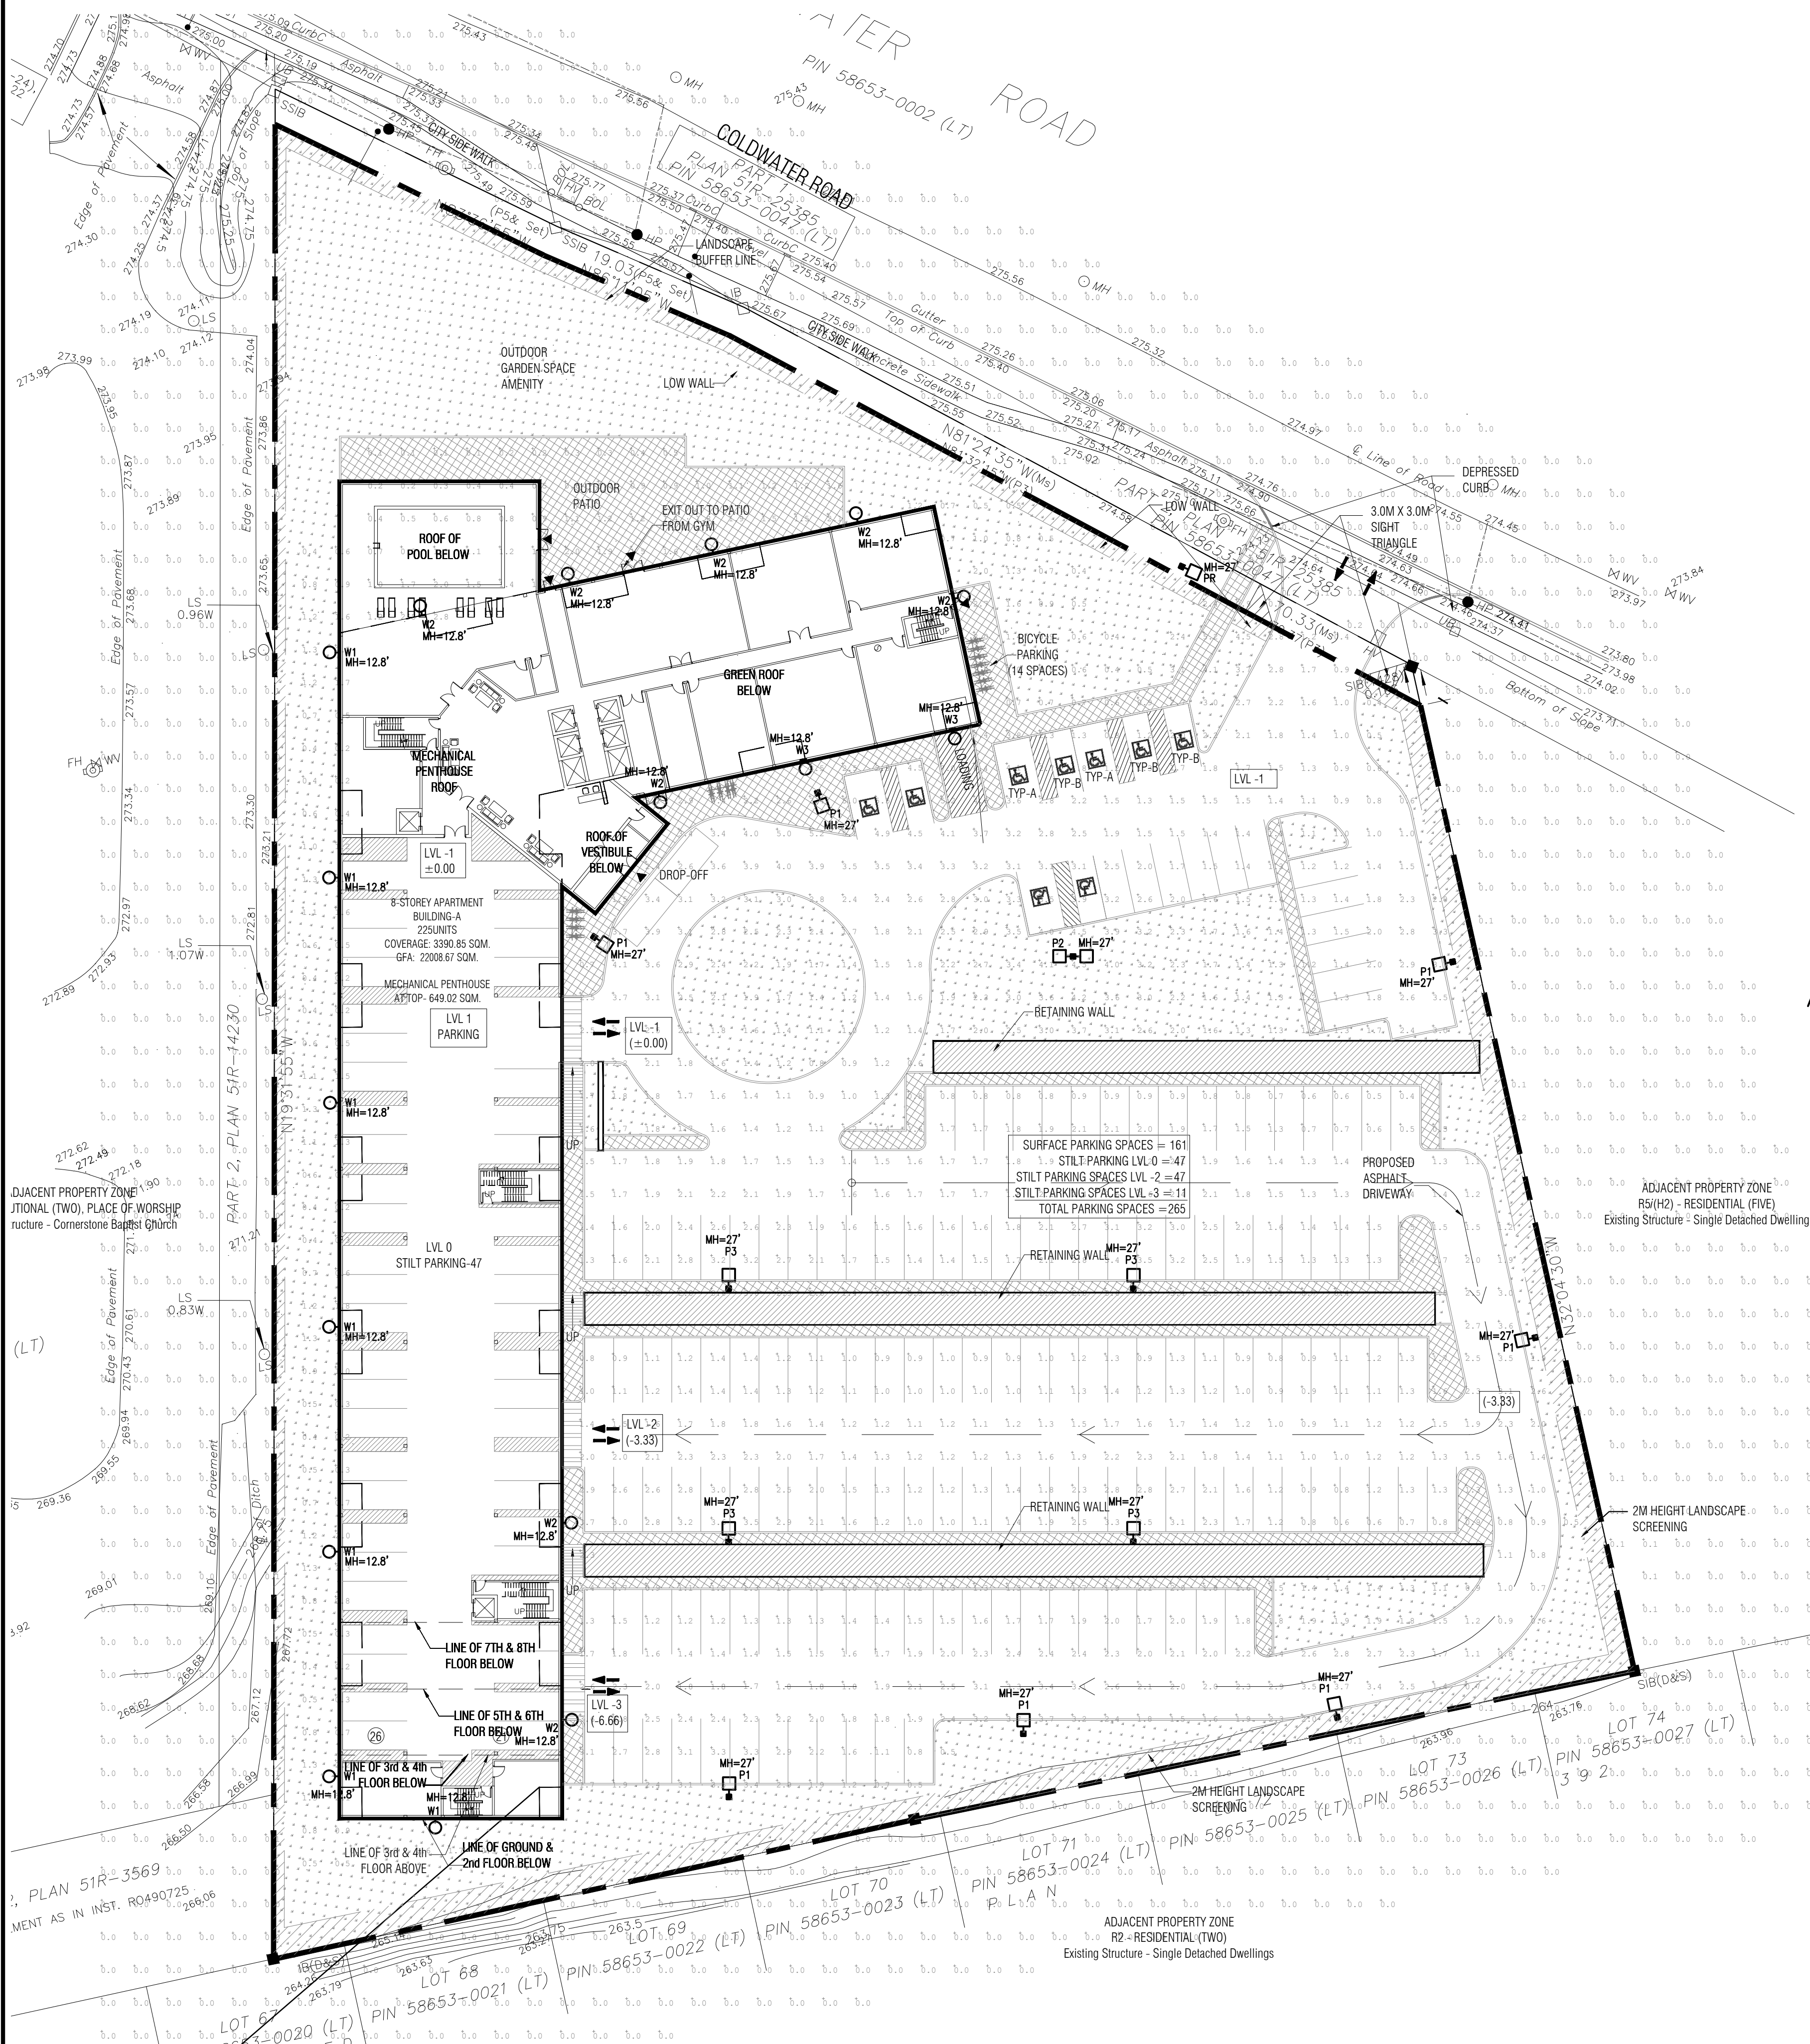


KEY PLAN
N.T.S.

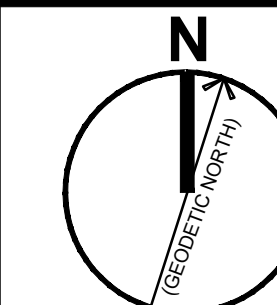

Symbol	Qty	Label	Arrangement	LLF	Description	Arr. Watts	Lum. Lumens	(MANUFAC)	BUG Rating	Remarks
☐ P1	7	P1	SINGLE	0.900	ECF-S-48L-900-WW-G2-BLC	133,0985	11880	Gardco by Signify	B1-U0-G2	Complete with 25' ROUND STEEL POLE ON A 2' CONCRETE BASE
☐ P2	1	P2	BACK-BACK	0.900	ECF-S-48L-900-WW-G2-3	135.1	16744	Gardco by Signify	B3-U0-G3	Complete with 25' ROUND STEEL POLE ON A 2' CONCRETE BASE
☐ P3	4	P3	SINGLE	0.900	ECF-S-48L-900-WW-G2-4	135.1	17518	Gardco by Signify	B2-U0-G3	Complete with 25' ROUND STEEL POLE ON A 2' CONCRETE BASE
☐ PR	1	PR	SINGLE	0.900	ECF-S-48L-900-WW-G2-RCL	133,0985	7625	Gardco by Signify	B0-U0-G2	Complete with 25' ROUND STEEL POLE ON A 2' CONCRETE BASE
○ W1	7	W1	SINGLE	0.900	121-16L-200-WW-C4-2	12.4	1350	Gardco by Signify	B1-U0-G0	
○ W2	9	W2	SINGLE	0.900	121-16L-530-WW-C4-4	28.1	2892	Gardco by Signify	B1-U0-G1	
○ W3	1	W3	SINGLE	0.900	121-32L-700-WW-C4-4	70.2	7732	Gardco by Signify	B1-U0-G2	

Label	CalcType	Units	Avg	Max	Min	Avg/Min	Max/Min
SIDE+BACK	Illuminance	Fc	1.00	3.1	0.1	10.00	31.00
LIGHTSPILL	Illuminance	Fc	0.01	0.2	0.0	N.A.	N.A.
SITE	Illuminance	Fc	1.91	7.4	0.4	4.78	18.50

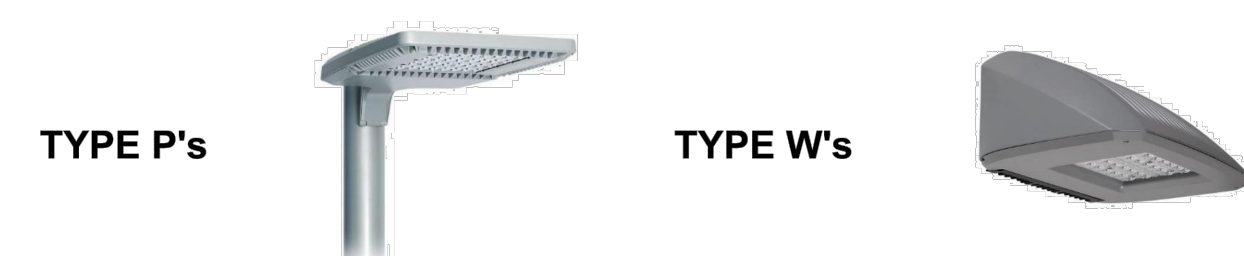

1 SITE PLAN - ELECTRICAL LAYOUT
E-1.1 1:350

No.	Date	Version	Dwn
2	19JULY2022	ISSUED FOR SPA	D.P.
1	27APRIL2022	ISSUED FOR SPA	D.P.

PROJECT:
**CONDOMINIUM
233,249,261
COLDWATER ROAD,
WEST, ORILLA**

DRAWING TITLE:
**SITE PLAN -
ELECTRICAL LAYOUT**

DRAWN BY: DP DATE: 26 APR 2022
CHECKED BY: RH SCALE: AS NOTED

PROJECT NO.: DRAWING NO.:
21-23 E-1.1